



**Proposed Prayer Hall & Social Centre Building Plan For  
LAMP LIGHTERS WORLD MISSION, At RDA Road Periyakallar 02.**

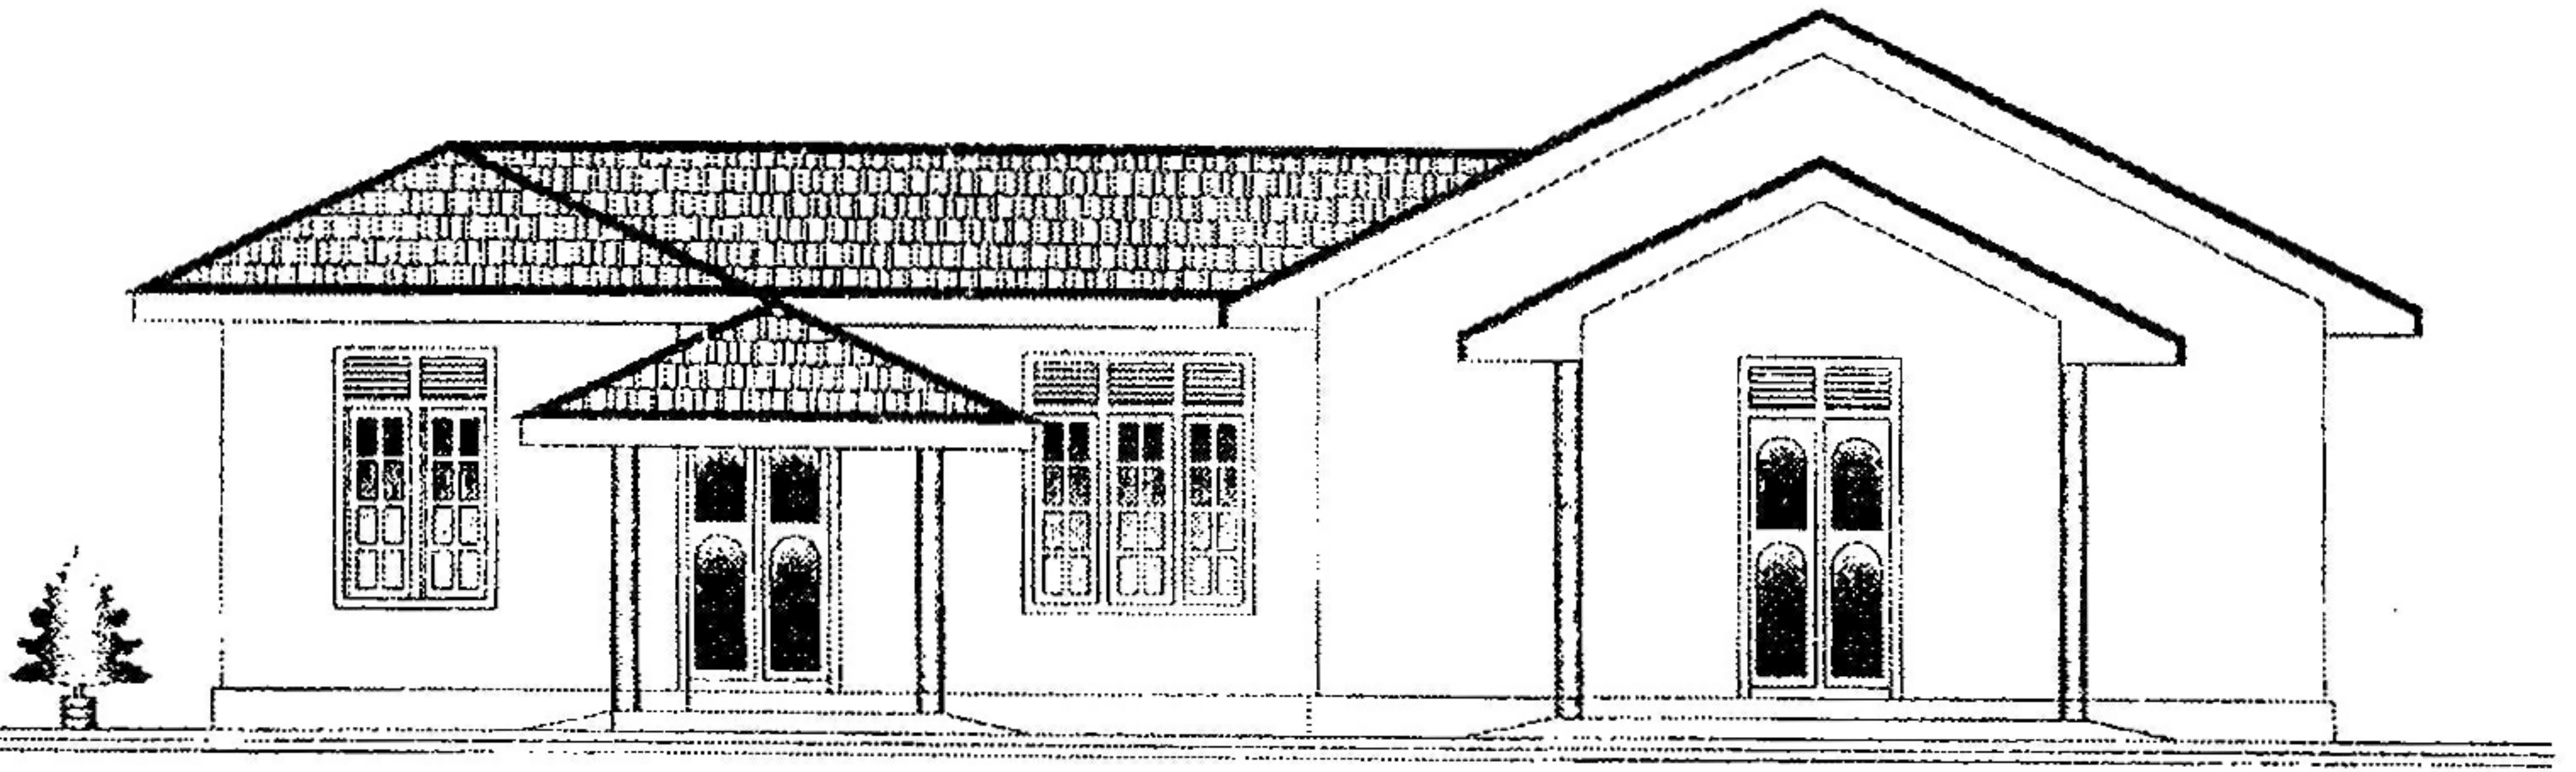

**FRONT ELEVATION**

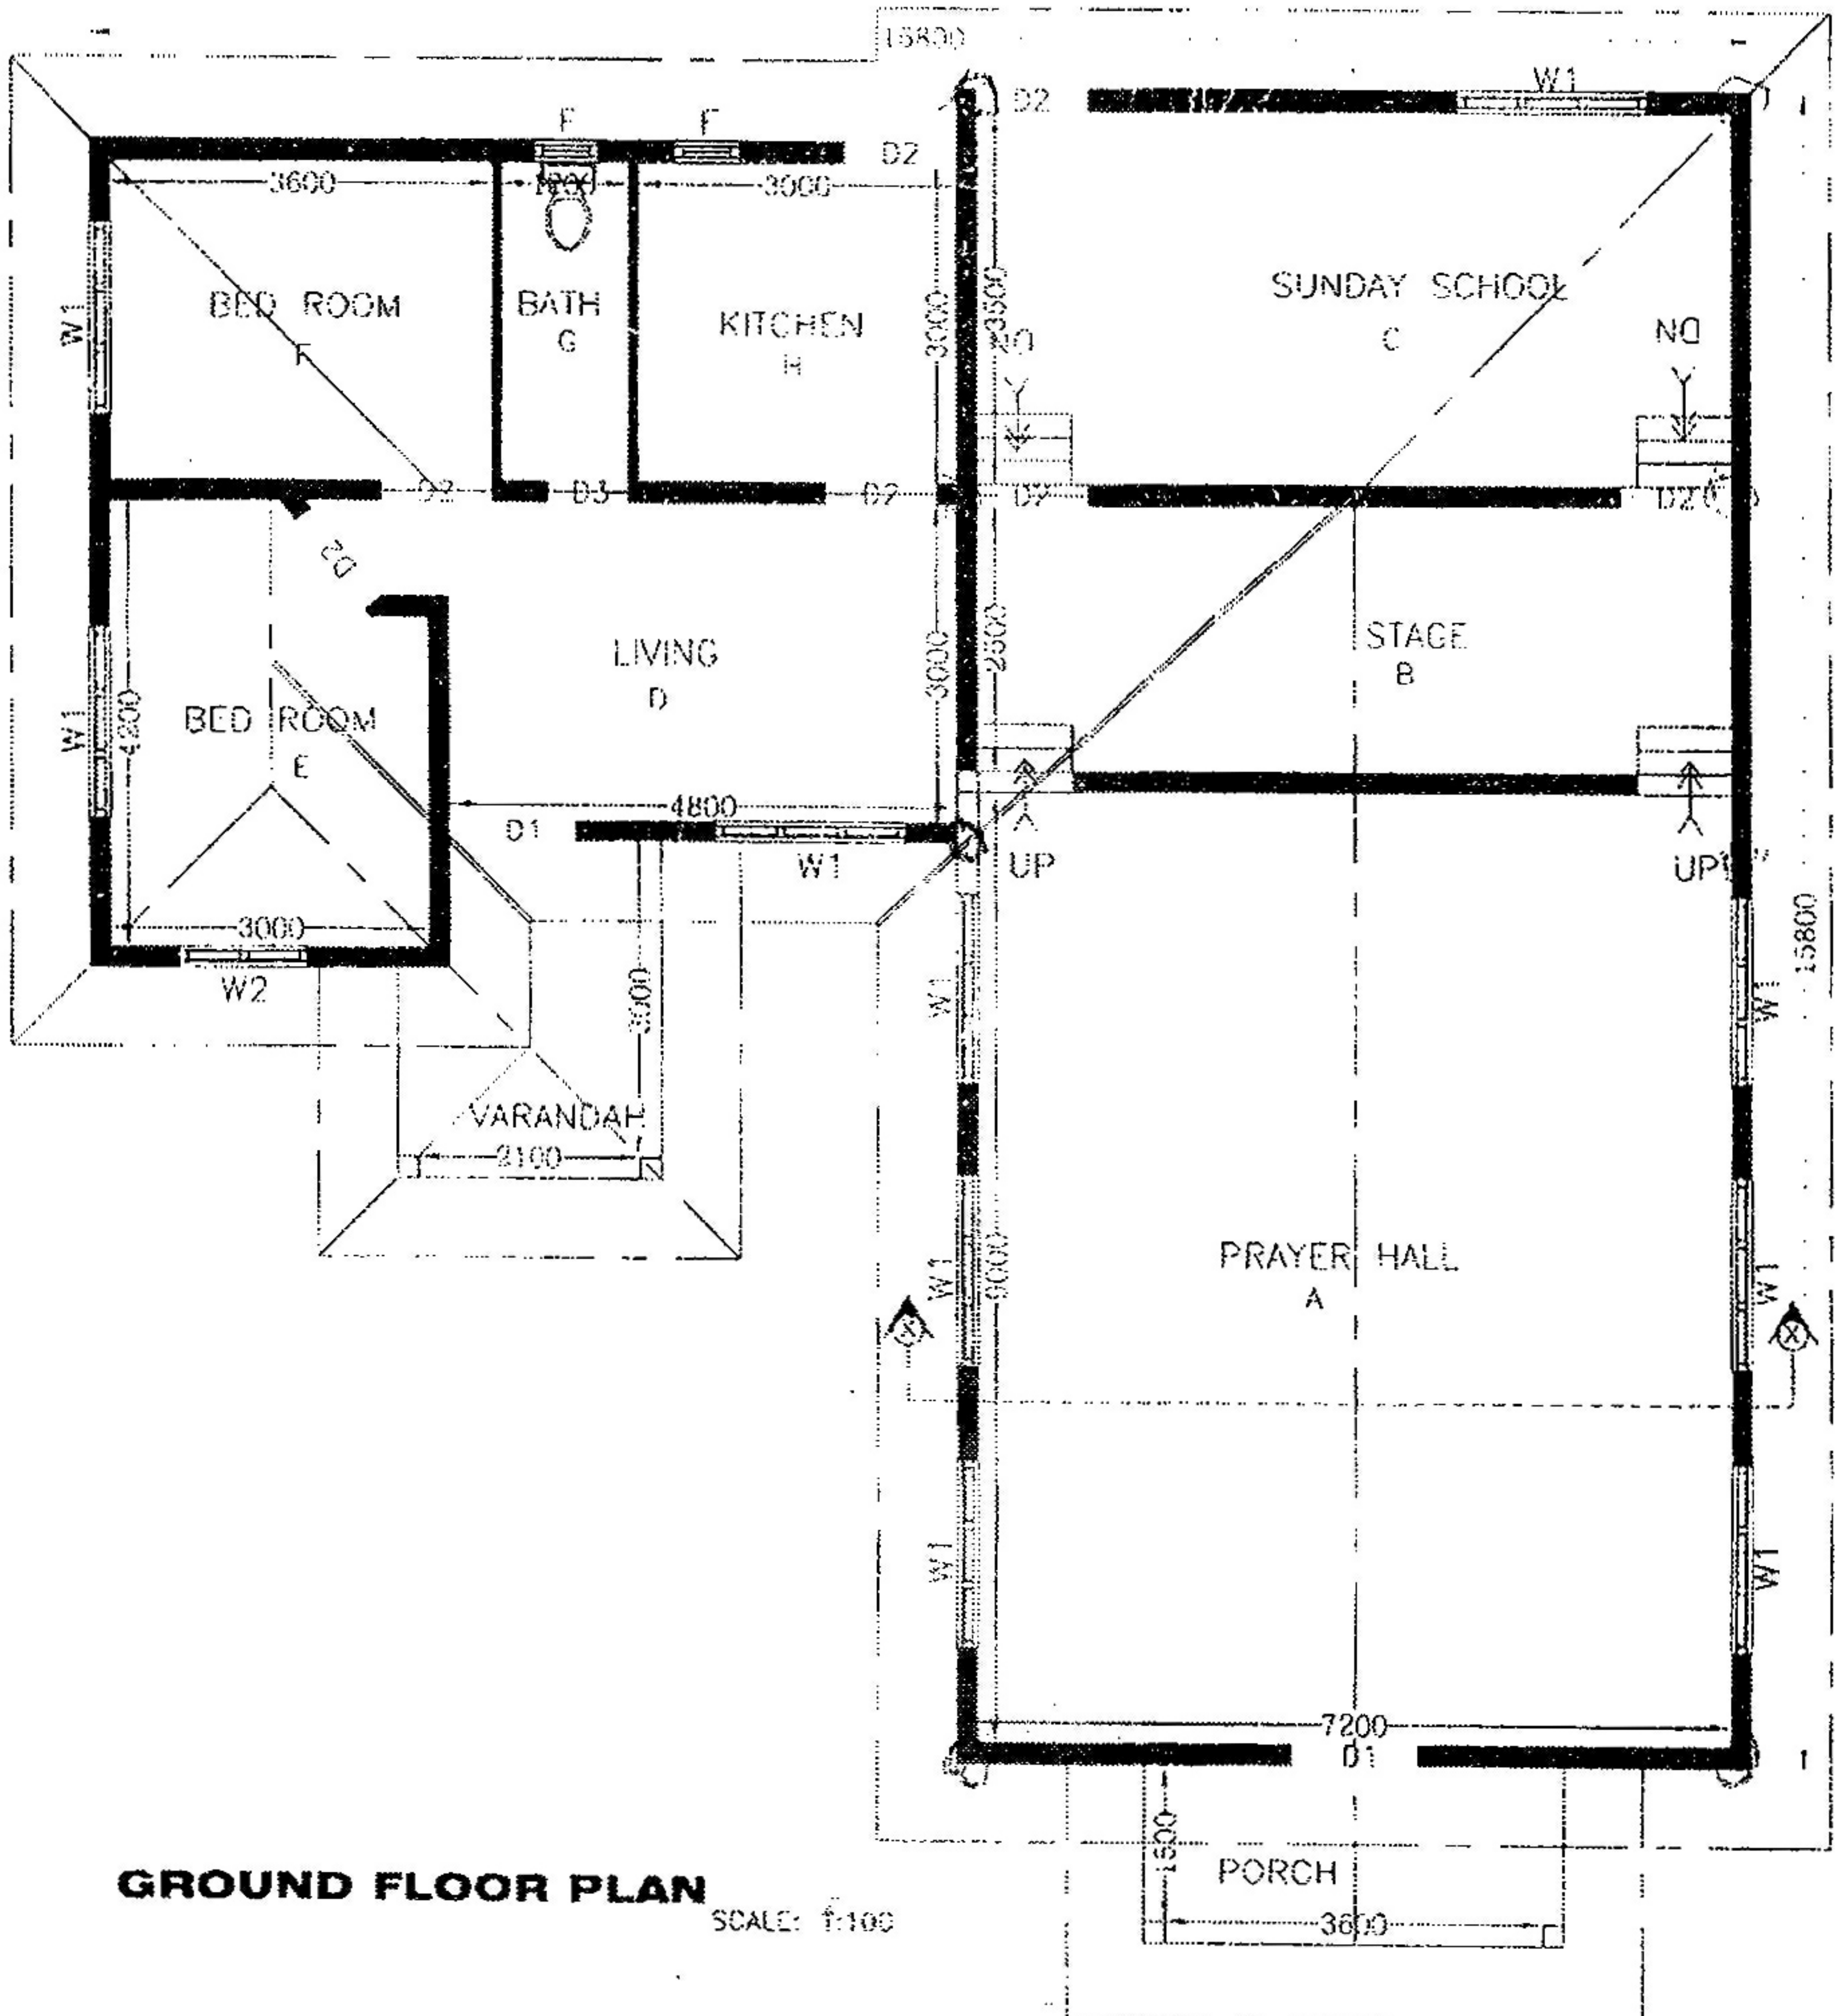

**GROUND FLOOR PLAN** SCALE: 1:100

SIGNATURE OF APPLICANT

*[Signature]*  
DRAWN BY  
**V. V. S. ARAN**